




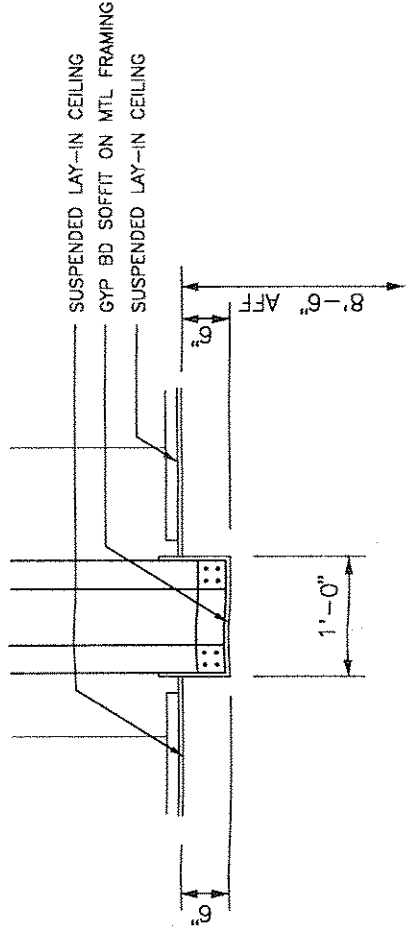


'A' - SOFFIT DETAIL
NO SCALE

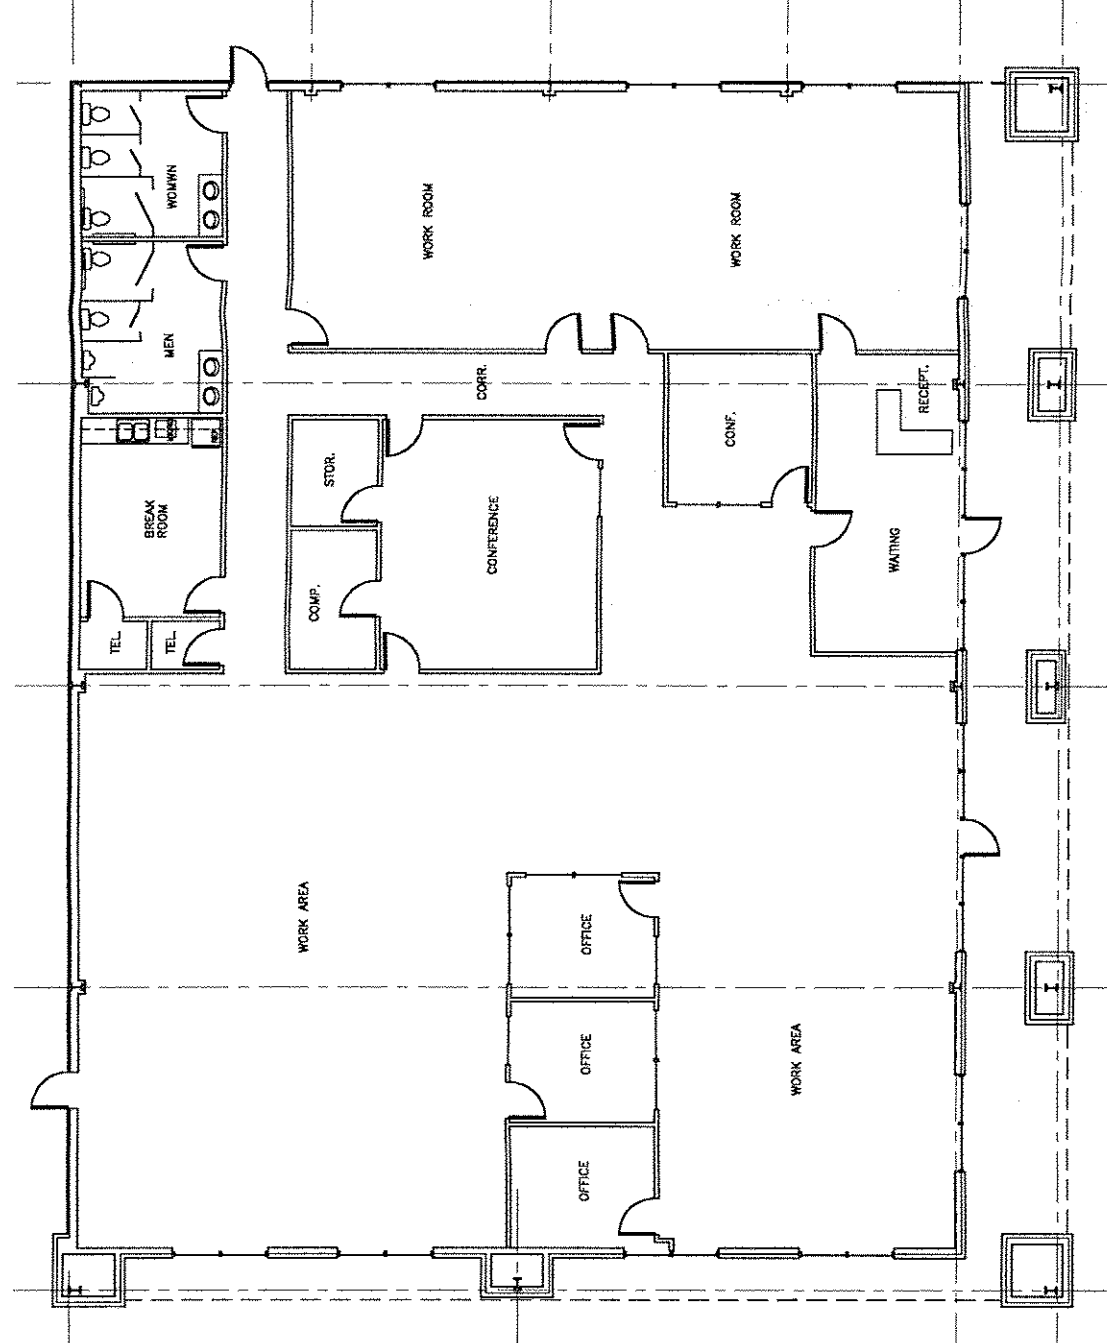

EXISTING FLOOR PLAN
SCALE 1/8" = 1'-0"

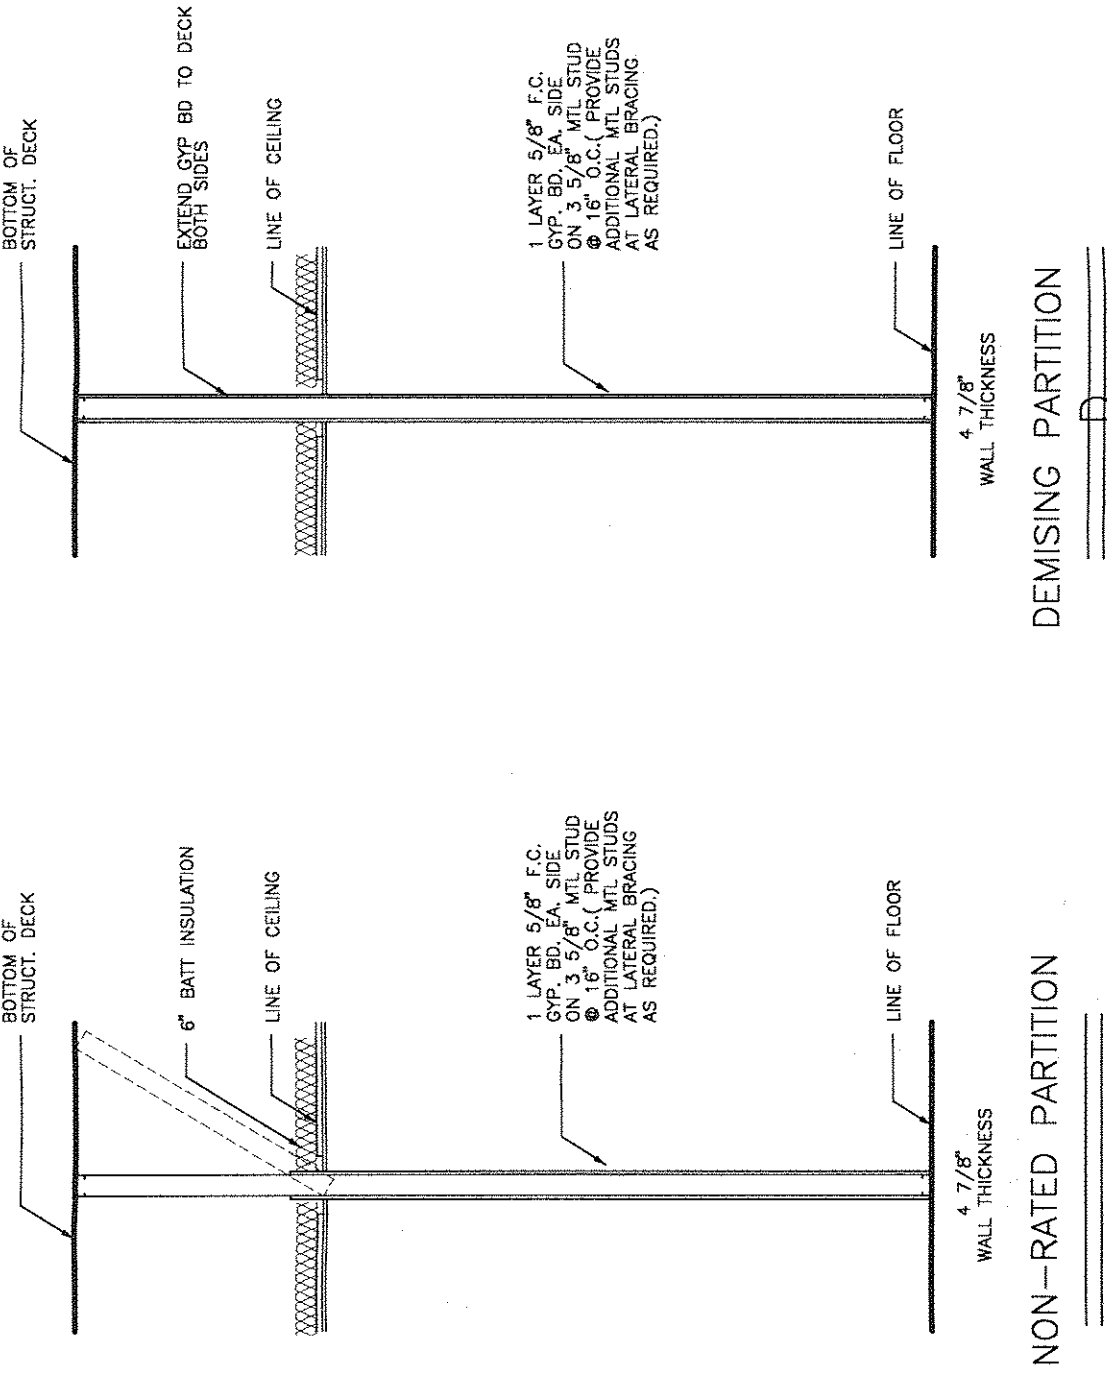

PARTITION TYPES
NO SCALE

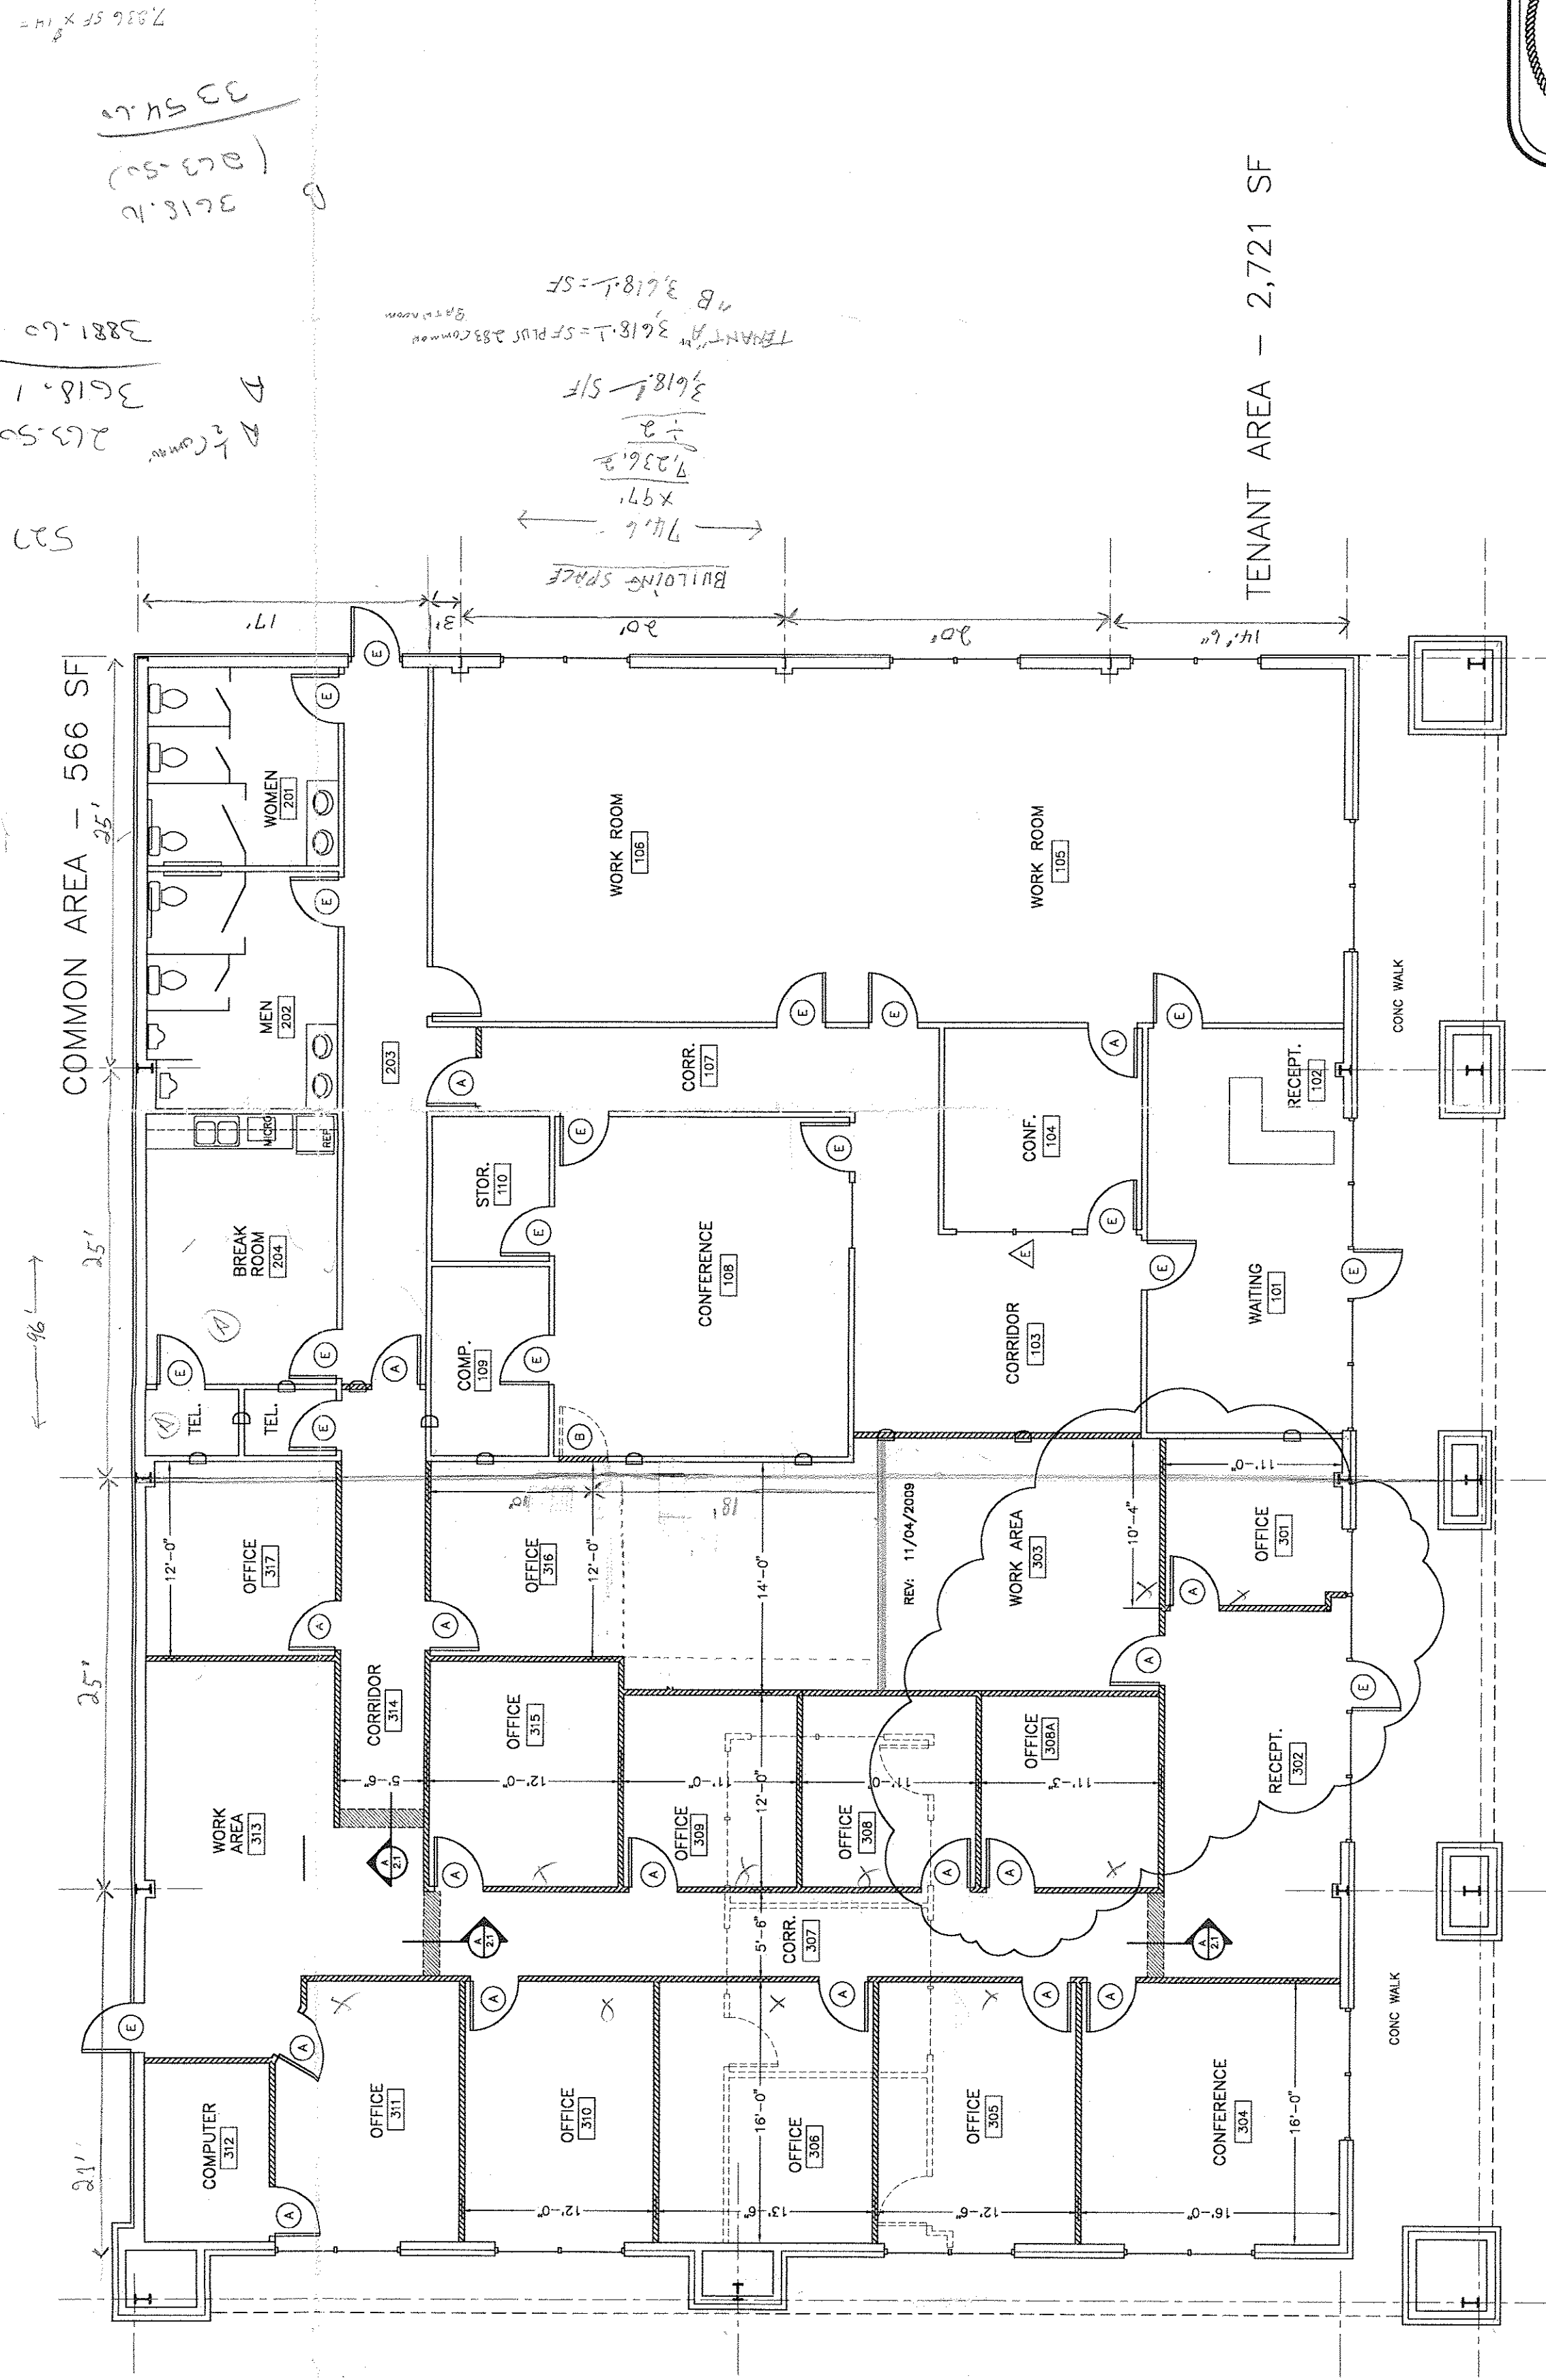

PROPOSED TENANT FLOOR PLAN
SCALE 1/8" = 1'-0"



WINDOW SCHEDULE
A EXISTING WINDOW TO REMAIN

PARTITION LEGEND
EXISTING PARTITION TO REMAIN
NEW DRYWALL PARTITION - REFER PART. TYPES
EXTG PARTITION TO BE REMOVED
TENANT DEMISING PART. - RE PART. TYPES


CEILING / WALL NOTE:
1. CLG HEIGHTS TO MATCH EXISTING.
2. PROVIDE LAY-IN CLG TO MATCH EXTG UNLESS SHOWN OTHERWISE.
3. GYP BD CLG SHOWN SHADED - 5/8" F.C.G.B. ON MTL FRAMING.
4. PROVIDE CLG & WALL EXPAN. JOINTS PER MFR RECS / 25' OC MAX.

GENERAL NOTES:
1. ALL WORK SHALL BE INSTALLED IN STRICT ACCORDANCE WITH ALL LOCAL BUILDING AND A.D.A. & A.N.S.I. CODES.
2. COORDINATE MILLWORK W/ OWNER, ANSI & A.D.A. REQ'TS.
3. REFER TO DOOR & WINDOW TYPES FOR SIZE & CONFIGURATION.
4. COORDINATE ALL FINISHES W/ OWNER.
5. CONTRACTOR SHALL BE RESPONSIBLE FOR THE DESIGN OF ALL MECH. ELECTRICAL & FIRE ALARM SYSTEMS.

MILLWORK NOTES:
1. ALL EXPOSED MILLWORK SURFACES SHALL BE PLASTIC LAMINATE ON 3/4" PARTICLE BOARD.
2. MILLWORK INTERIOR BOX CONSTRUCTION SHALL BE 3/4" MELAMINE PARTICLE BOARD.
3. SUBMIT SAMPLES OF ALL MATERIALS & COLORS FOR OWNER APPROVAL.
4. COORDINATE FIELD DIMS AND VERIFY ALL OWNER EQUIPMENT REQ'TS.

DOOR SCHEDULE
A 3'-0" X 6'-8" SOLID CORE WOOD / METAL FRAME
B EXISTING DOOR TO BE REMOVED
C EXISTING DOOR TO REMAIN
NOTE:
HARDWARE SHALL COMPLY W/ ALL LOCAL & ADA REGULATIONS.

CLARK CONSTRUCTION, INC.
1000 WEST GRAND BOULEVARD
OKLAHOMA CITY, OKLAHOMA 73102
REV. 11/04/2009

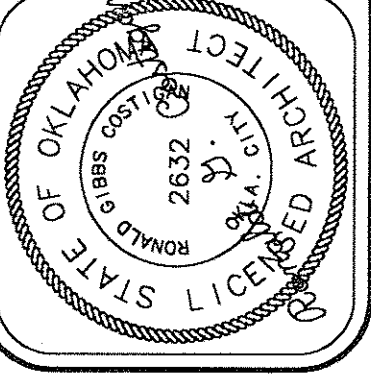

PROPOSED TENANT RENOVATION FOR
MIDDLE POINTE OFFICE BUILDING
SOUTH DOUGLAS BOULEVARD
MIDWEST CITY, OKLAHOMA

COSTIGAN & ASSOCIATES, INC.
ARCHITECTURE
ENGINEERING
PLANNING
CONSULTING
TELEPHONE 405/234-0000
FAX 405/234-0001
1000 WEST GRAND BOULEVARD
OKLAHOMA CITY, OKLAHOMA 73102

SHEET NUMBER:
A2.1
OF 1 SHEETS

DATE: 7/6/2009
SHEET TITLE:
BUILDING PLAN